


PARTS LIST


ITEM NO	COMPONENT	PART NO.	DESCRIPTION	MANUFACTURER	QTY	REMARKS
1	FOUNTAIN	-	41-15/16"H x 25-1/2"W BUDDHA FACE - GFRC	GIST	1	COLOR OPTIONAL
2		-	15-1/2"W x 9"H HALF ROUND BUILT IN RISER - GFRC	GIST	1	COLOR OPTIONAL
3		-	31-1/2"L x 7-1/4"H HALF ROUND BASE - GFRC	GIST	1	COLOR OPTIONAL
4	TUBING	-	3/8" DIA COPPER TUBE	-	1	PRE-INSTALLED
5		-	1-1/4" DIA x 1-1/4"LG PVC PIPE SLEEVE PLAIN END	-	1	PRE-INSTALLED
6	PARTS BAG	A104	1/2" ID X 48" VINYL TUBE	-	1	
7		A104	PLASTIC CLAMP	-	1	
8		A104	1-1/4" DIA RUBBER PLUG	-	1	
9		A104	SHIM PLASTIC	EZ - SHIM	3	
10	PUMP	-	MODEL 1.9 - PT 505, 225 GPH SUBMERSIBLE PUMP	JEBAO	1	
11						




3 ASSEMBLY
SCALE: N.T.S.

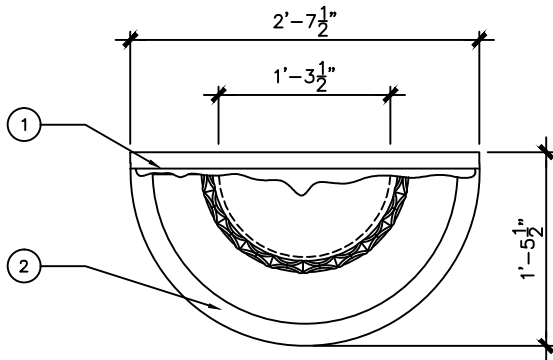


1 PLAN VIEW
SCALE: 3/4"=1'

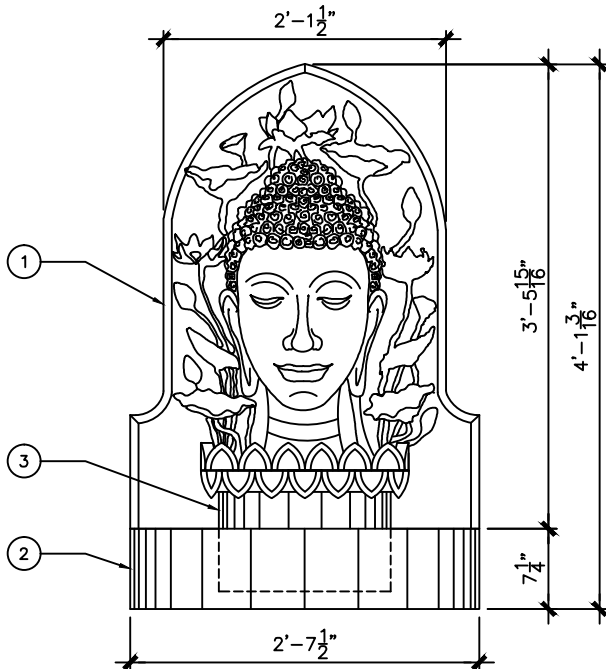

2 ELEVATION
SCALE: 3/4"=1'

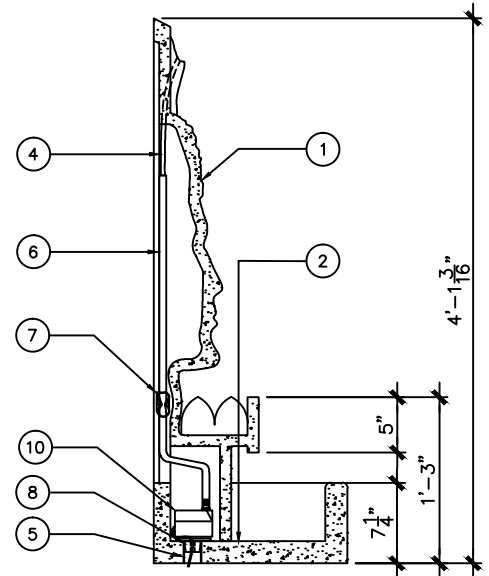

4 SECTION
SCALE: 3/4"=1'

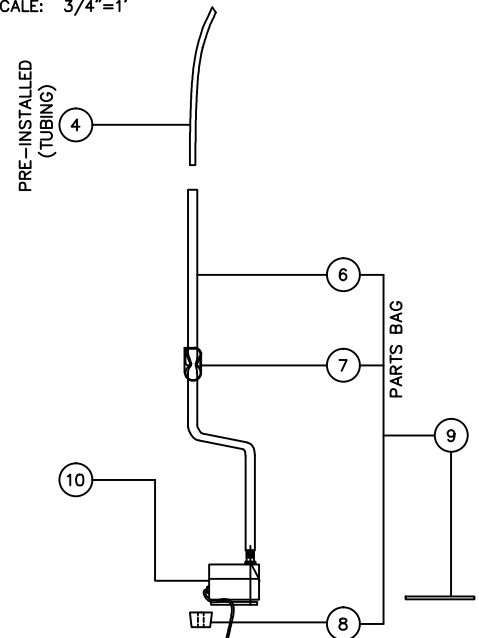

5 PIPE ASSEMBLY
SCALE: 1"=1'

NOTE:

Electrical supply must conform with local & national regulation/codes. If in doubt consult an electrician.

To ease connections hot water may be used to soften PVC tubing. Pump and plumbing details may vary.

Precautions should be taken to prevent damage from water freezing in reservoir.



995 Governor Dr. #103
El Dorado Hills, CA 95762

866 382-8600

info@yardart.com

BUDDHA FOUNTAIN

PRODUCT
BUDDHA FOUNTAIN
DRAWING DATE
07-26-07

DWG NO. / SKU:
BUDF

SHEET NO. 1 OF 1

COPYRIGHT 2008 GIST DECOR 2012 GIST PRODUCTS ALL RIGHTS RESERVED